



[illegible]


809 MAIN
809 MAIN STREET LOUISVILLE, COLORADO 80027
FINAL PLANNED UNIT DEVELOPMENT & SPECIAL REVIEW USE

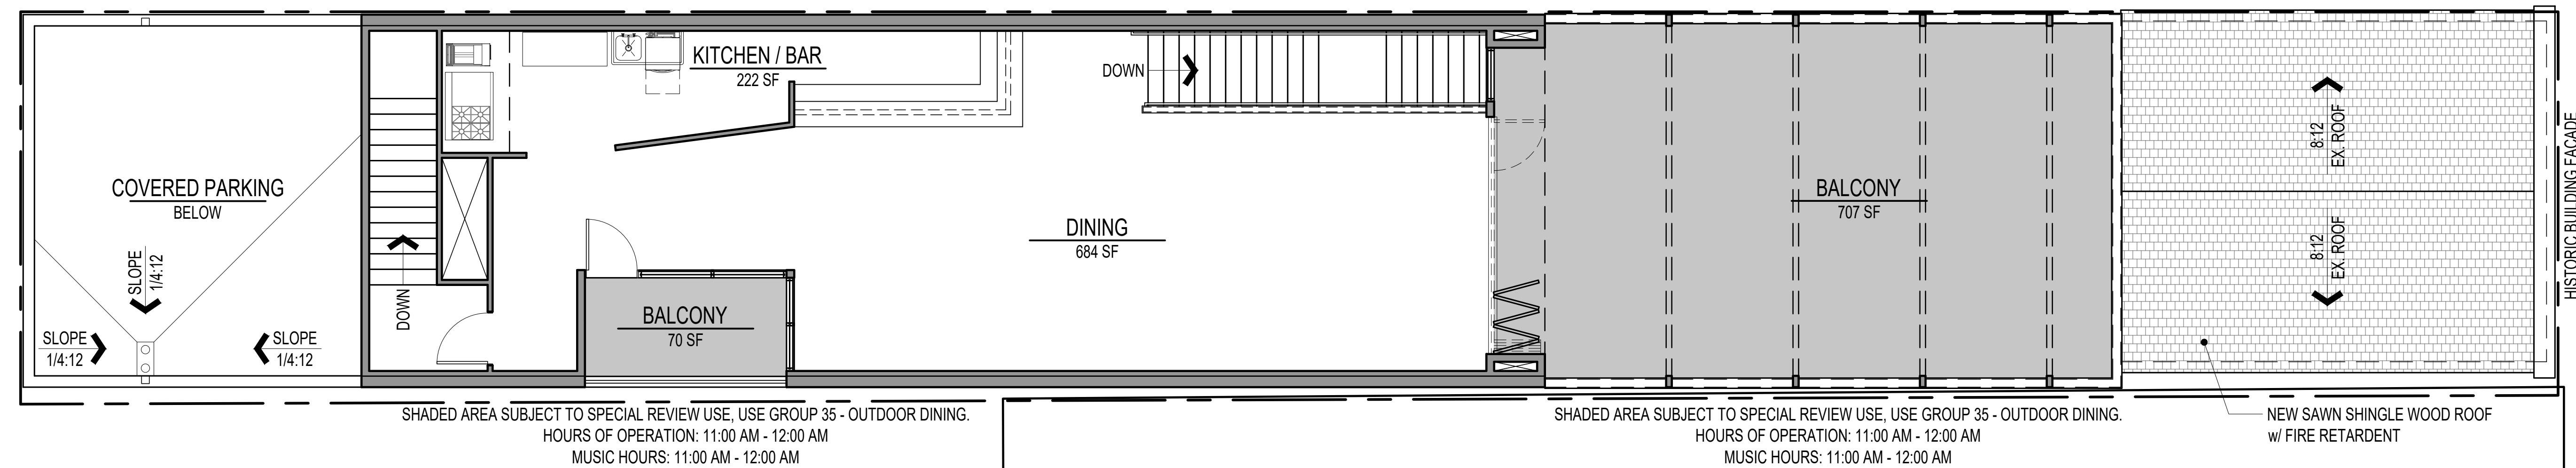

2ND FLOOR PLAN


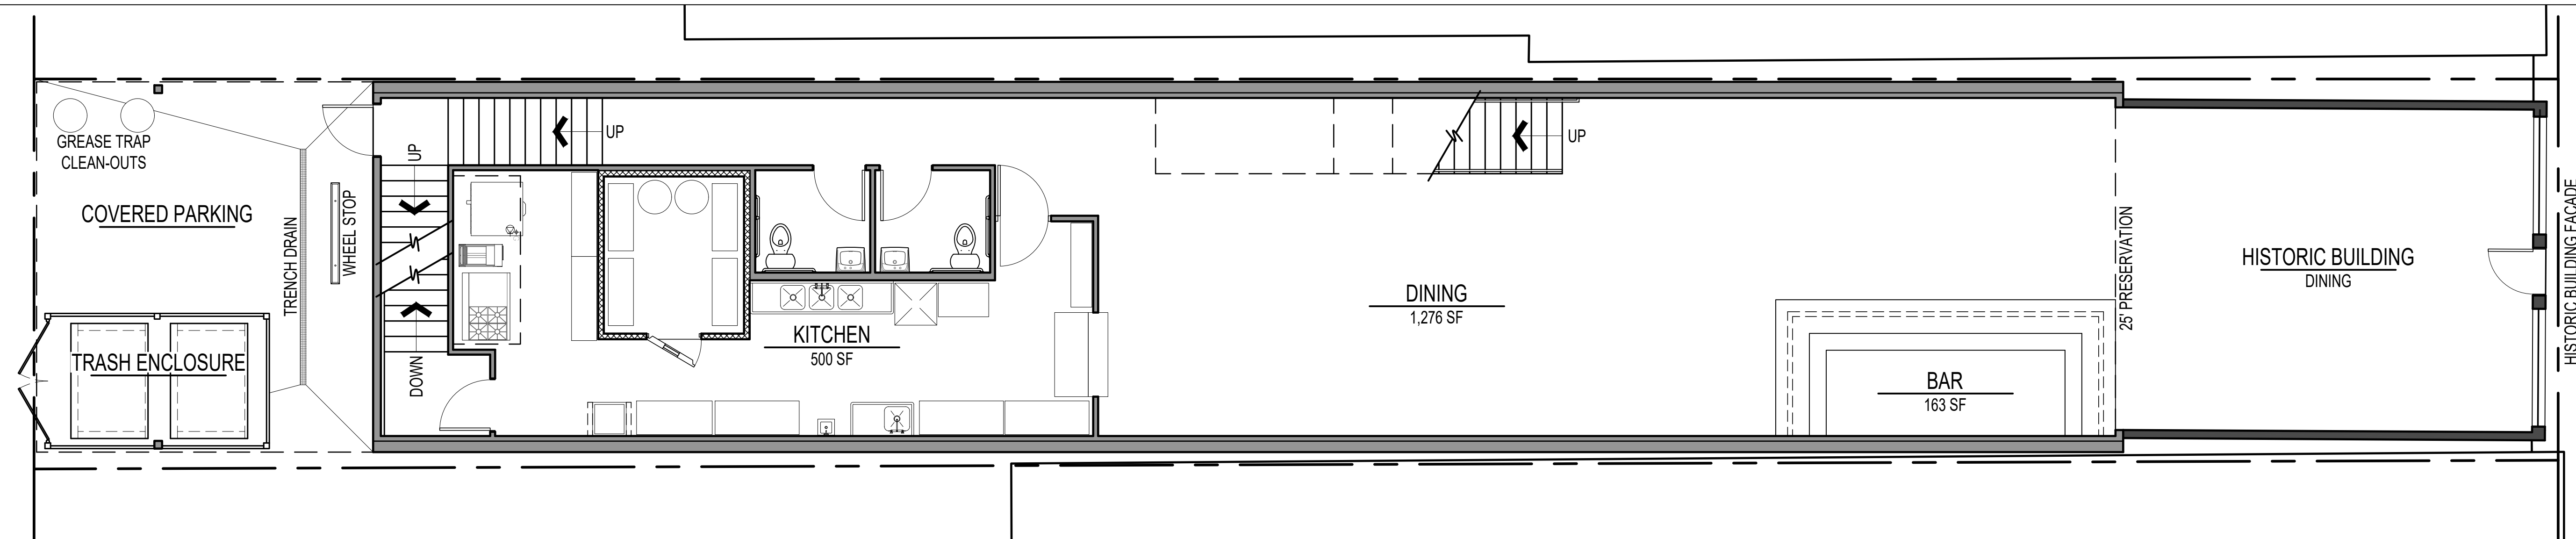


1ST FLOOR PLAN

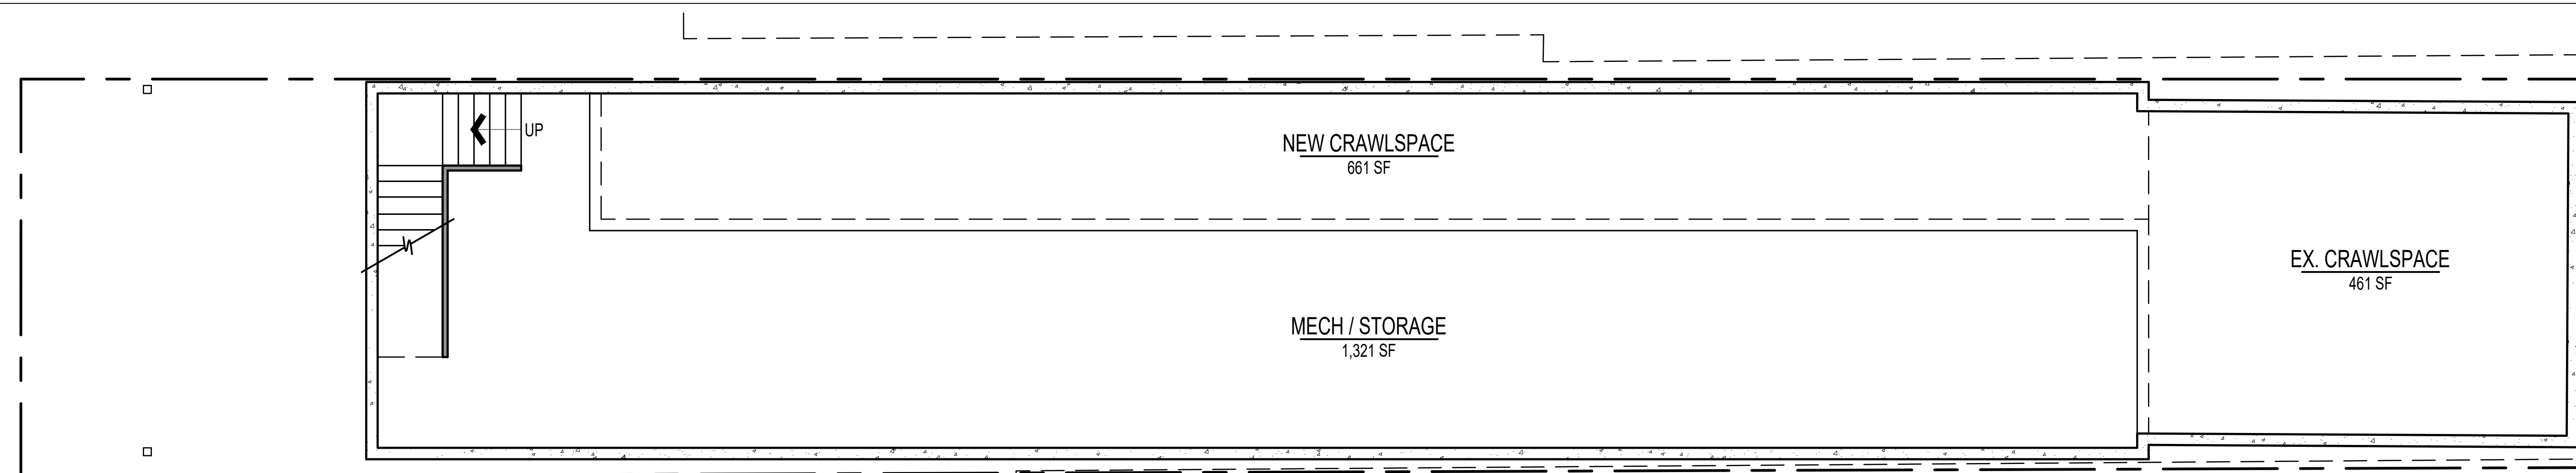


BASEMENT FLOOR PLAN

809 MAIN
809 MAIN STREET LOUISVILLE, COLORADO 80027
FINAL PLANNED UNIT DEVELOPMENT & SPECIAL REVIEW USE

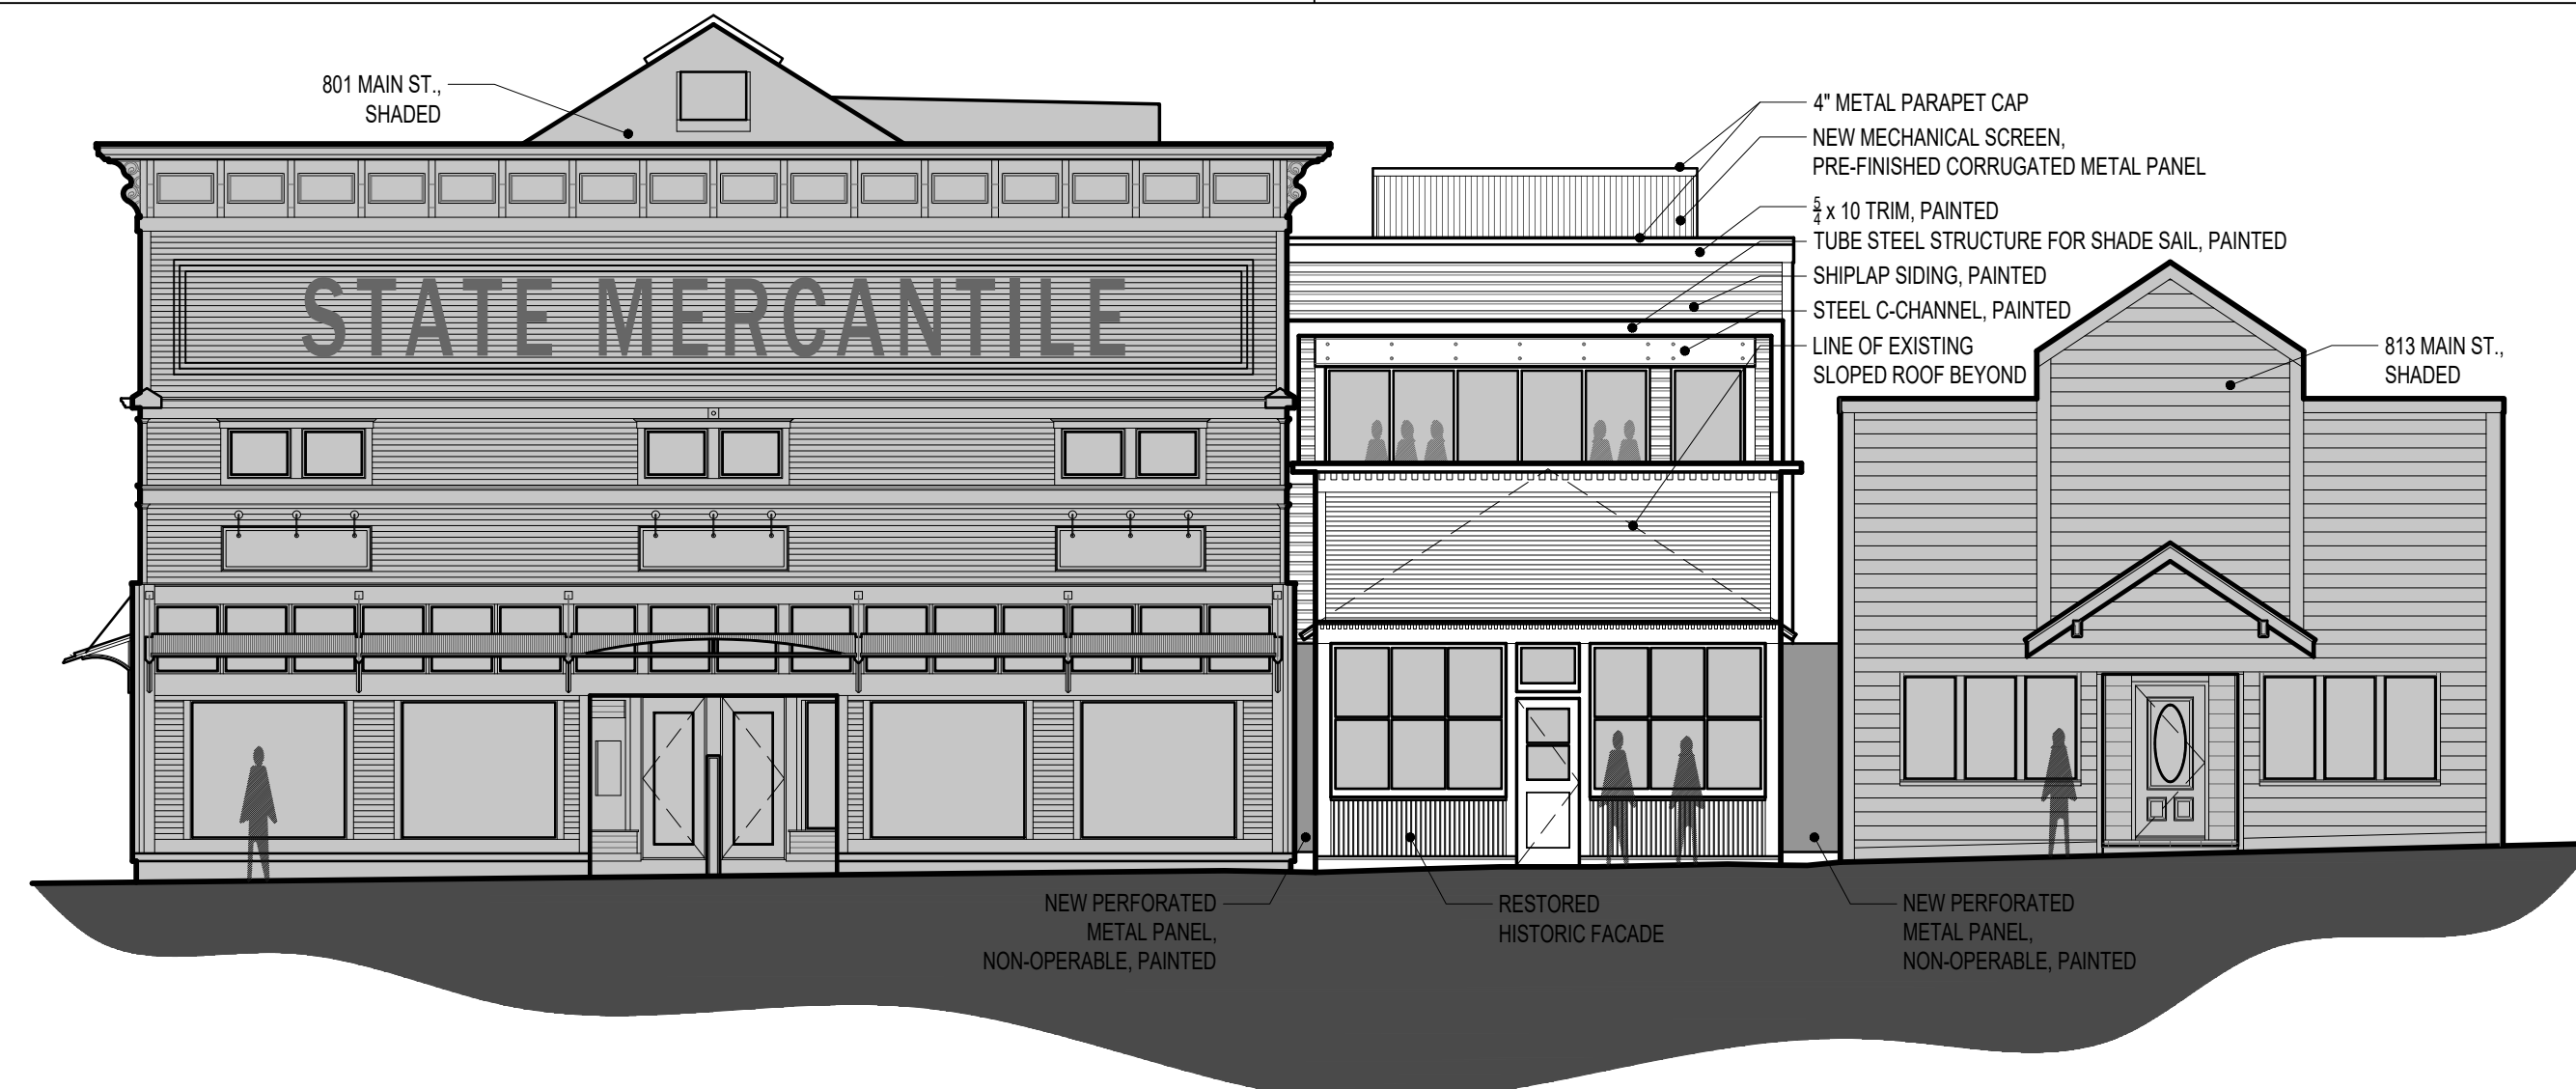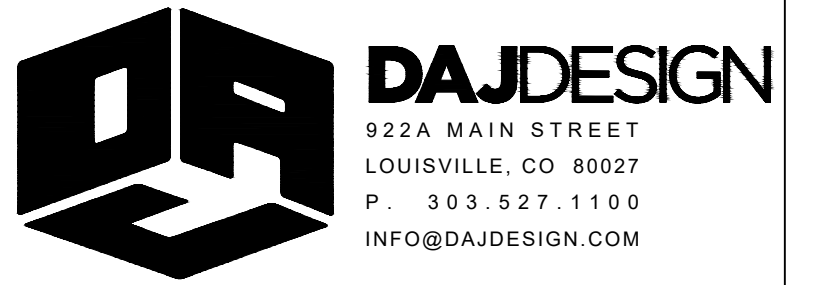


EAST ELEVATION
SCALE: 1/8" = 1' - 0"

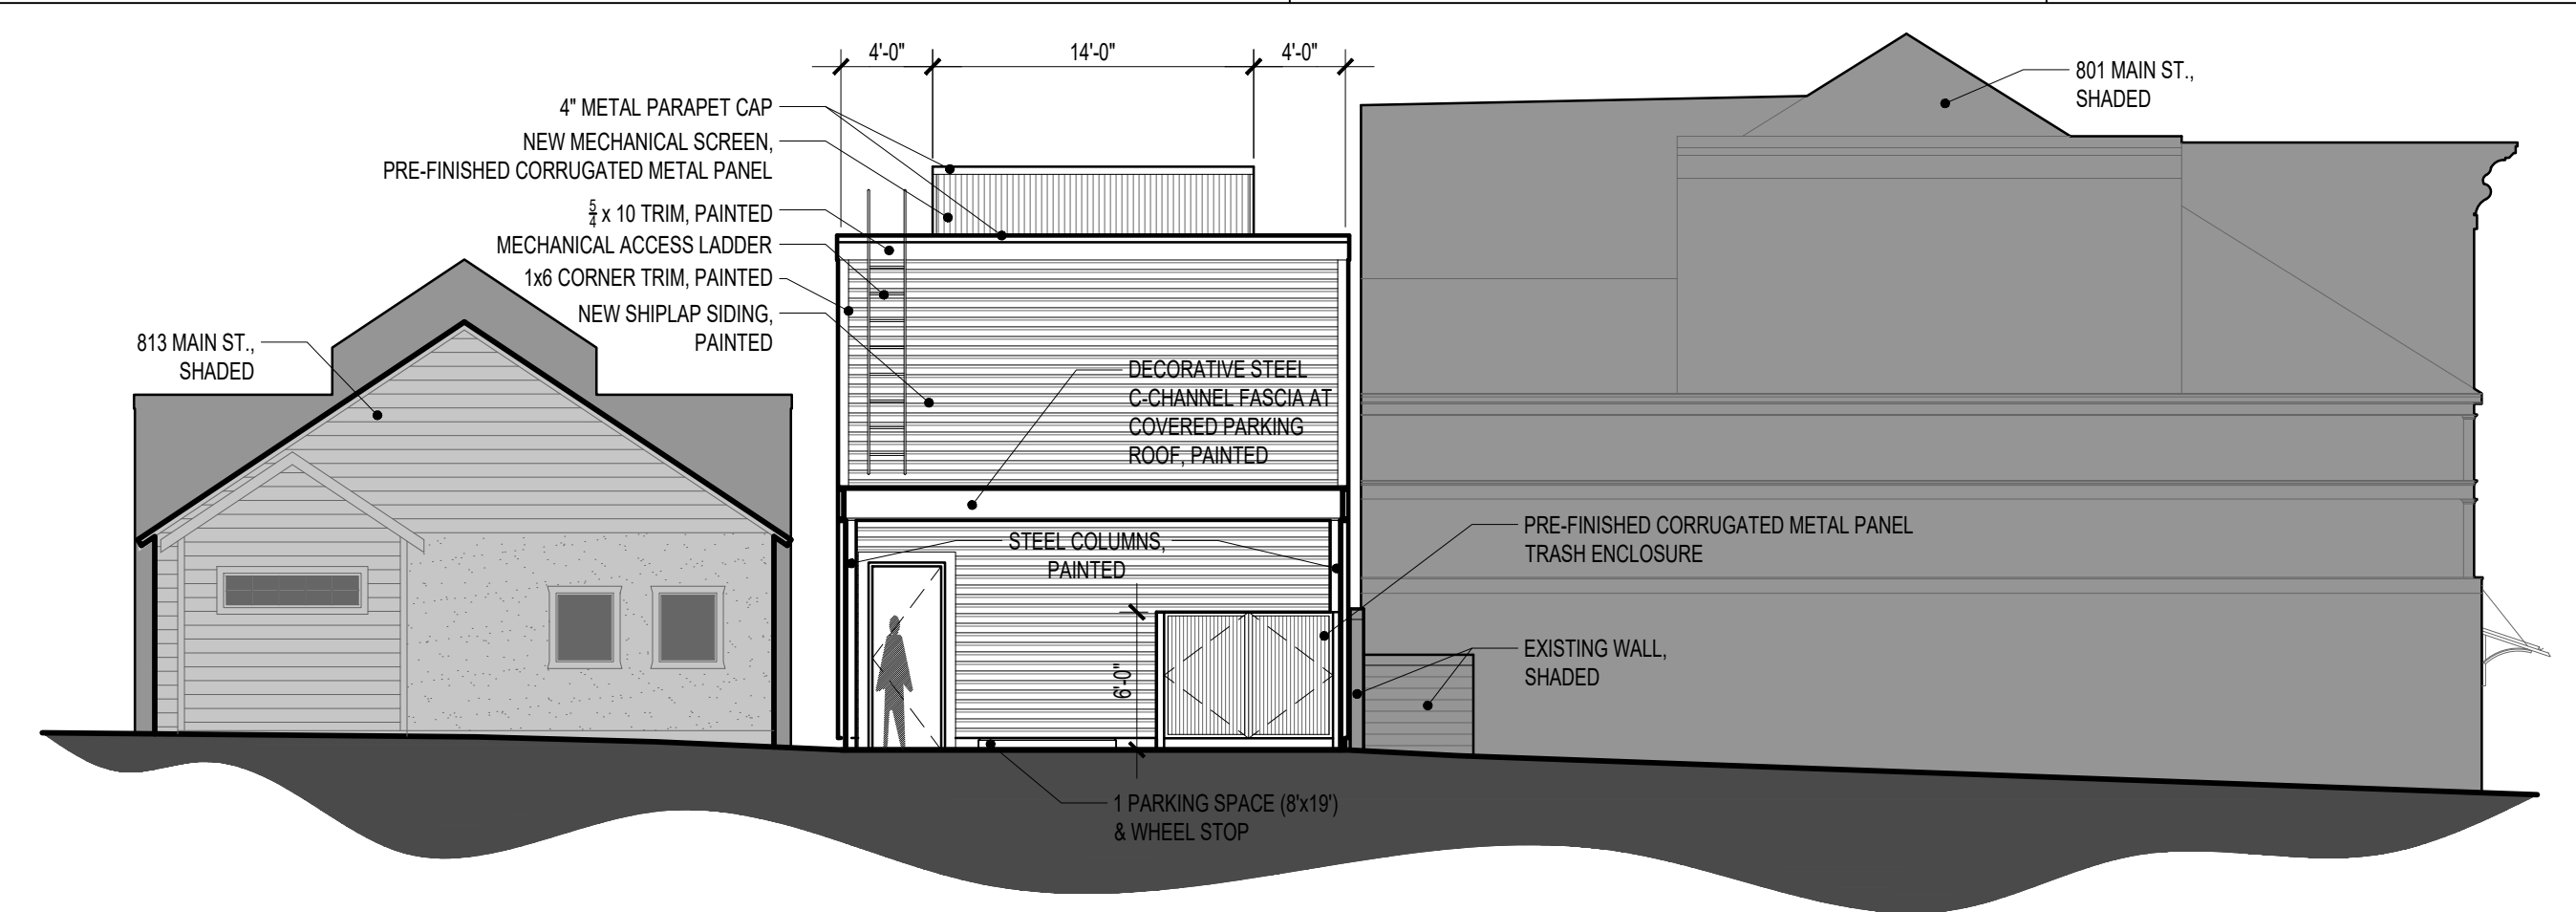

WEST ELEVATION
SCALE: 1/8" = 1' - 0"



SOUTH ELEVATION
SCALE: 1/8" = 1' - 0"

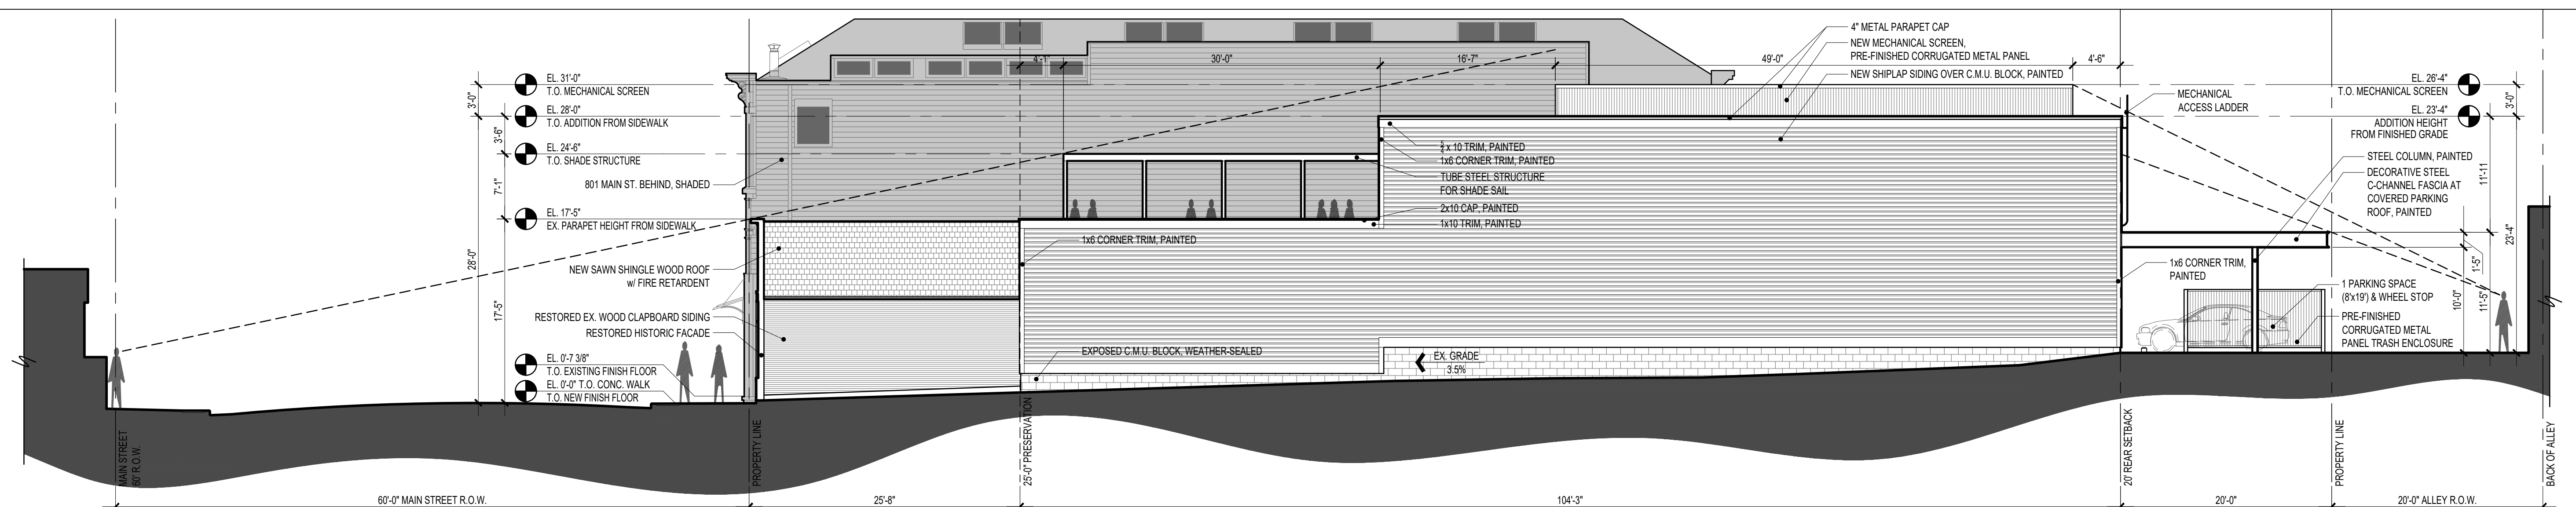

NORTH ELEVATION
SCALE: 1/8" = 1' - 0"

809 MAIN

809 MAIN STREET LOUISVILLE, COLORADO 80027
FINAL PLANNED UNIT DEVELOPMENT



**BOULDER
ENGINEERING**
1717 15TH STREET
BOULDER, CO 80302
P. 303.444.6038
STAFF@BOULDERENGINEERING.COM



DAJDESIGN
922A MAIN STREET
LOUISVILLE, CO 80027
P. 303.527.1100
INFO@DAJDESIGN.COM

Schedule											
Symbol	Label	Quant.	Manufacturer	Description	Lamp	Number Lamps	Filename	Lumens Per Lamp	Light Loss Factor	Wattage	Catalog Number
	F1	48	TOKISTAR	EXHIBITOR - 3000K - 24" SPACING		1	UB-EX_IW_S14-F.ies	50	1	1.8	UB-EX_IW_S14-F
	W1	1	Lithonia Lighting	WDGE1 LED WITH P1 - PERFORMANCE PACKAGE, 3000K, 80CRI, VISUAL COMFORT FORWARD OPTIC		1	WDGE1_LED_P1_30 K_80CRI_VF.ies	1161	1	10.0002	WDGE1 LED P1 30K 80CRI VF
	W2	1	Cree Inc	60 Watt Equivalent, A19 Screw Base Lamp, with white opaque dome lens covering LED array, 2700K CCT	SSC base up Serial Number: PL13056-001	1	A19-60W-P1-xxK-E26-U1_PL13056-001A IES File.ies	879	1	9.5	A19-60W-P1-27K-E26-U1

Luminaire Locations											
Location								Aim			
No.	Label	X	Y	Z	MH	Orientation	Tilt	X	Y	Z	
1	W1	439.52	309.45	9.00	9.00	270.46	0.00	439.52	309.45	0.00	
2	W2	569.59	308.75	10.00	10.00	270.00	0.00	569.59	308.75	0.00	

Statistics							
Description	Symbol	Avg	Max	Min	Max/Min	Avg/Min	
Lower Level	+	0.1 fc	5.5 fc	0.0 fc	N/A	N/A	






WDGE1 LED
Architectural Wall Sconce



Specifications
Depth (D1): 5.5"
Depth (D2): 1.5"
Height: 8"
Width: 9"
Weight: 9 lbs
(without options)

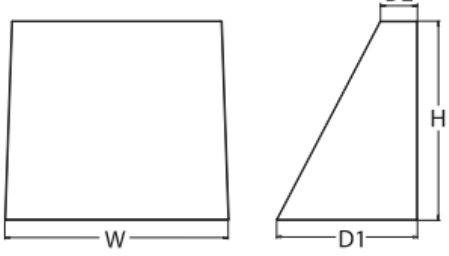

Introduction

The WDGE LED family is designed to meet specifier's every wall-mounted lighting need in a widely accepted shape that blends with any architecture. The clean rectilinear design comes in four sizes with lumen packages ranging from 1,200 to 25,000 lumens, providing true site-wide solution.


WDGE1 delivers up to 2,000 lumens with a soft, non-pixelated light source, creating a visually comfortable environment. The compact size of WDGE1, with its integrated emergency battery backup option, makes it an ideal over-the-door wall-mounted lighting solution.

WDGE LED Family Overview											
Luminaire	Standard EM, 0°C	Cold EM, -20°C	Sensor	Lumens (4000K)							
				P1	P2	P3	P4	P5	P6		
WDGE1 LED	4W	--	--	1,200	2,000	--	--	--	--	--	--
WDGE2 LED	10W	18W	Standalone / r/light	1,200	2,000	3,000	4,500	6,000	--	--	--
WDGE3 LED	15W	18W	Standalone / r/light	7,500	8,500	10,000	12,000	--	--	--	--
WDGE4 LED	--	--	Standalone / r/light	12,000	16,000	18,000	20,000	22,000	25,000	--	--

Ordering Information

EXAMPLE: WDGE1 LED P2 40K 80CRI VF MVOLT SRM PE DDBXD

Series	Package	Color Temperature	CRI	Distribution	Voltage	Mounting					
WDGE1 LED	P1	27K 30K 35K 40K 50K	2700K 3000K 3500K 4000K 5000K	80CRI 90CRI	VF VW	Visual comfort forward throw Visual comfort wide					
	P2				MVOLT 347	Shipped included SRM Surface mounting bracket ICW Indirect Canopy Ceiling Washer bracket (dry/damp locations only) Shipped separately AWS 3/8inch Architectural wall spacer PBBW Surface-mounted back box (top, left, right conduit entry)					
Options						Finish					
EAHH1	Emergency battery backup, Certified in CA Title 20 ABCEBIS (40W, 0° C min)					DDBXD Dark bronze					
PE*	PhotoCell, Button type					DDBLD Black					
DS	Dual switching (comes with 2 drivers and 2 light engines; see page 3 for details)					DNAXD Natural aluminum					
DMG	0-10V dimming wires pulled outside fixture (for use with an external control, ordered separately)					DNAXD White					
BCE	Bottom conduit entry for back box (PBBW), Total of 4 entry points.					DNAXD White					
						DSSTD Sandstone					
Accessories						NOTES					
Critical and elevated materials.						1 50K not available in 90CRI.					
WDGE1PBBW DDBXD U WDGE1 Ultra-thin Architectural Wall Spacer (specify finish)						2 347V not available with EAHH, DS or PE.					
WDGE1PBBW DDBXD U WDGE1 surface-mounted back box (specify finish)						3 E26/U1 not available with PE or DS.					
						4 PE not available with DS. Not qualified for E26. Not available with EAHH.					

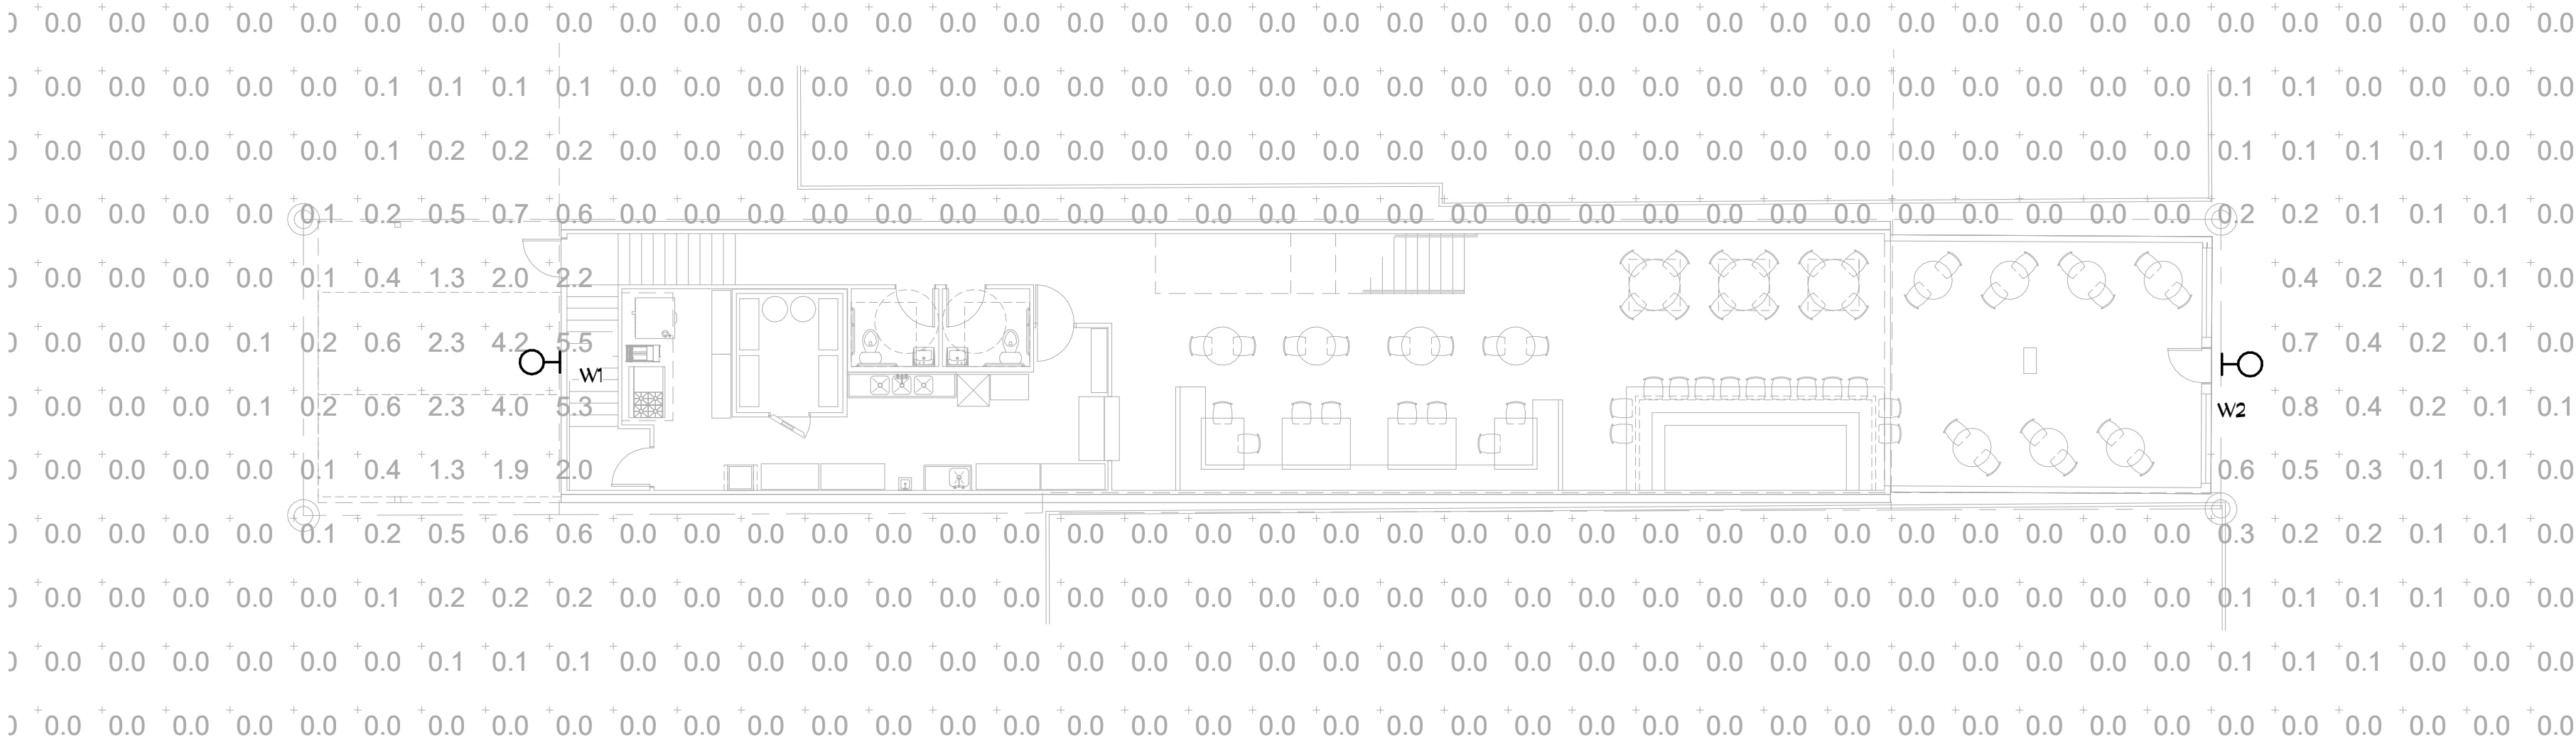

LOWER LEVEL PHOTOMETRIC PLAN
3/32" = 1'-0"
0 4 8 12 16 20